



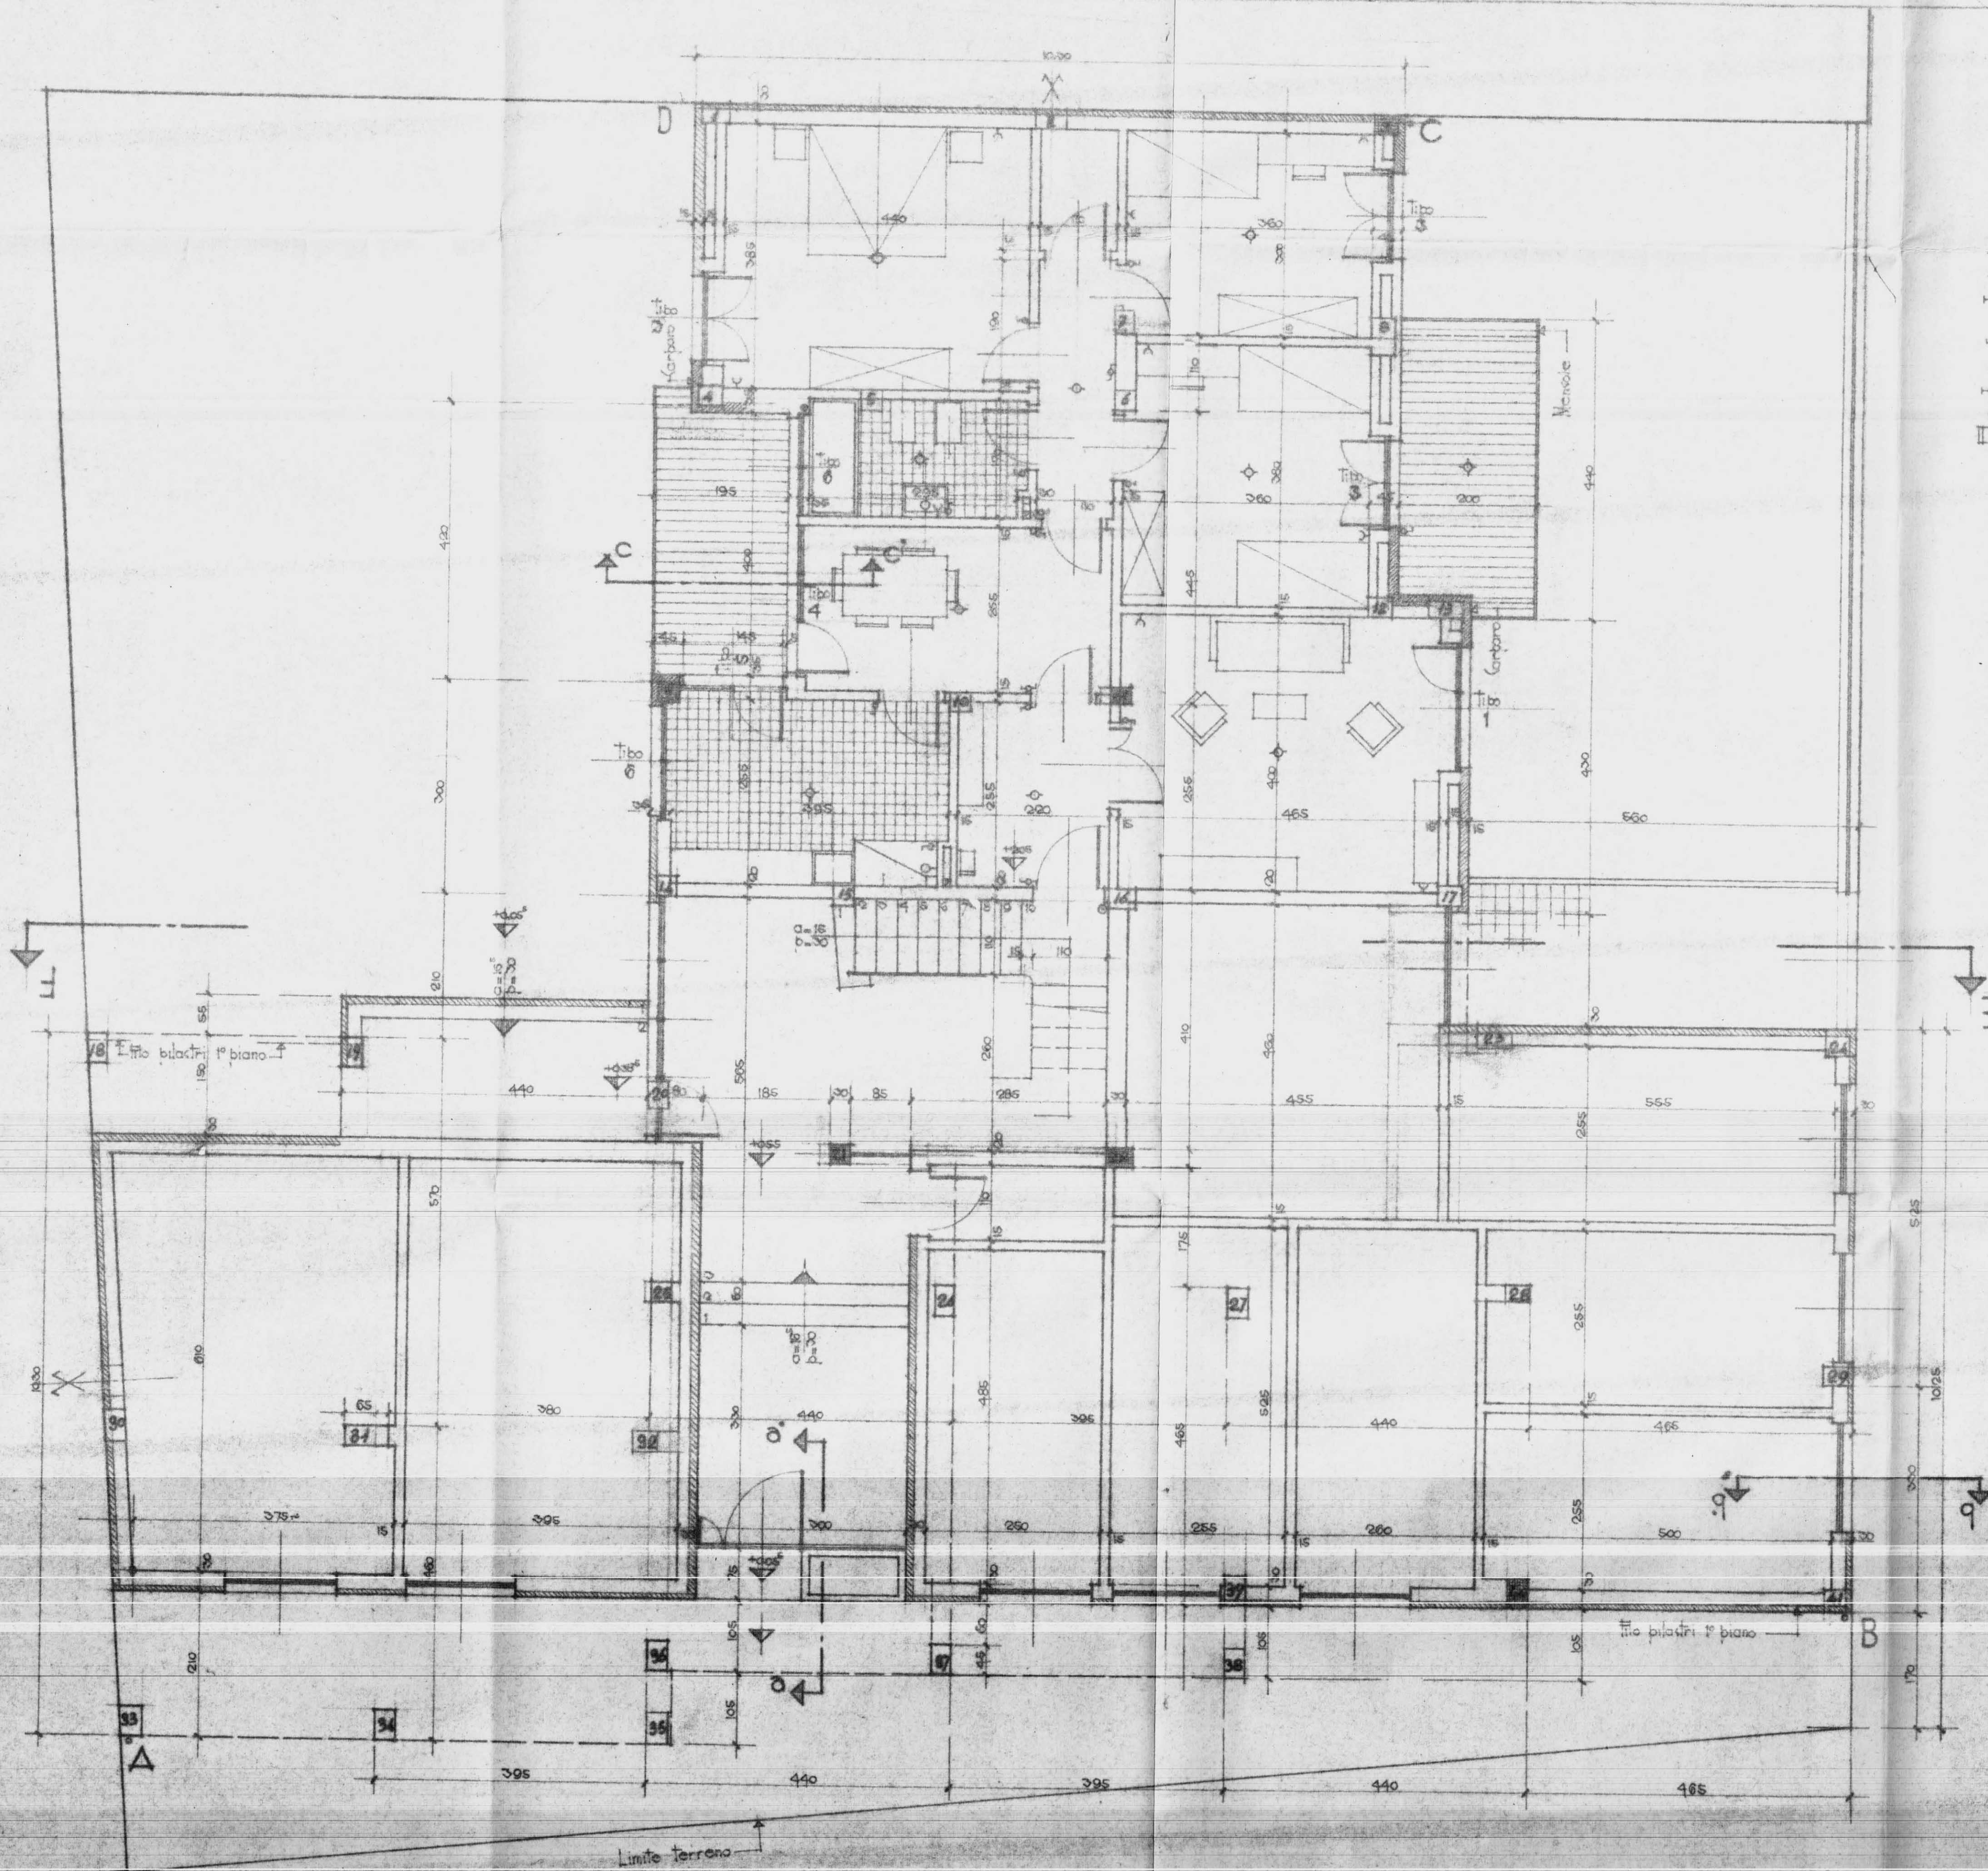


- LEGENDA**
- ◊ Lampada semplice da soffitto
 - " " deviato
 - ⊙ " " da parete
 - ⌞ Interruttore
 - ⌞ Deviatore
 - ⌞ Commutatore
 - ⌞ Presa di corrente
 - ⊙ Cambello da parete
 - Contatore generale

STRADA DI 8 m.

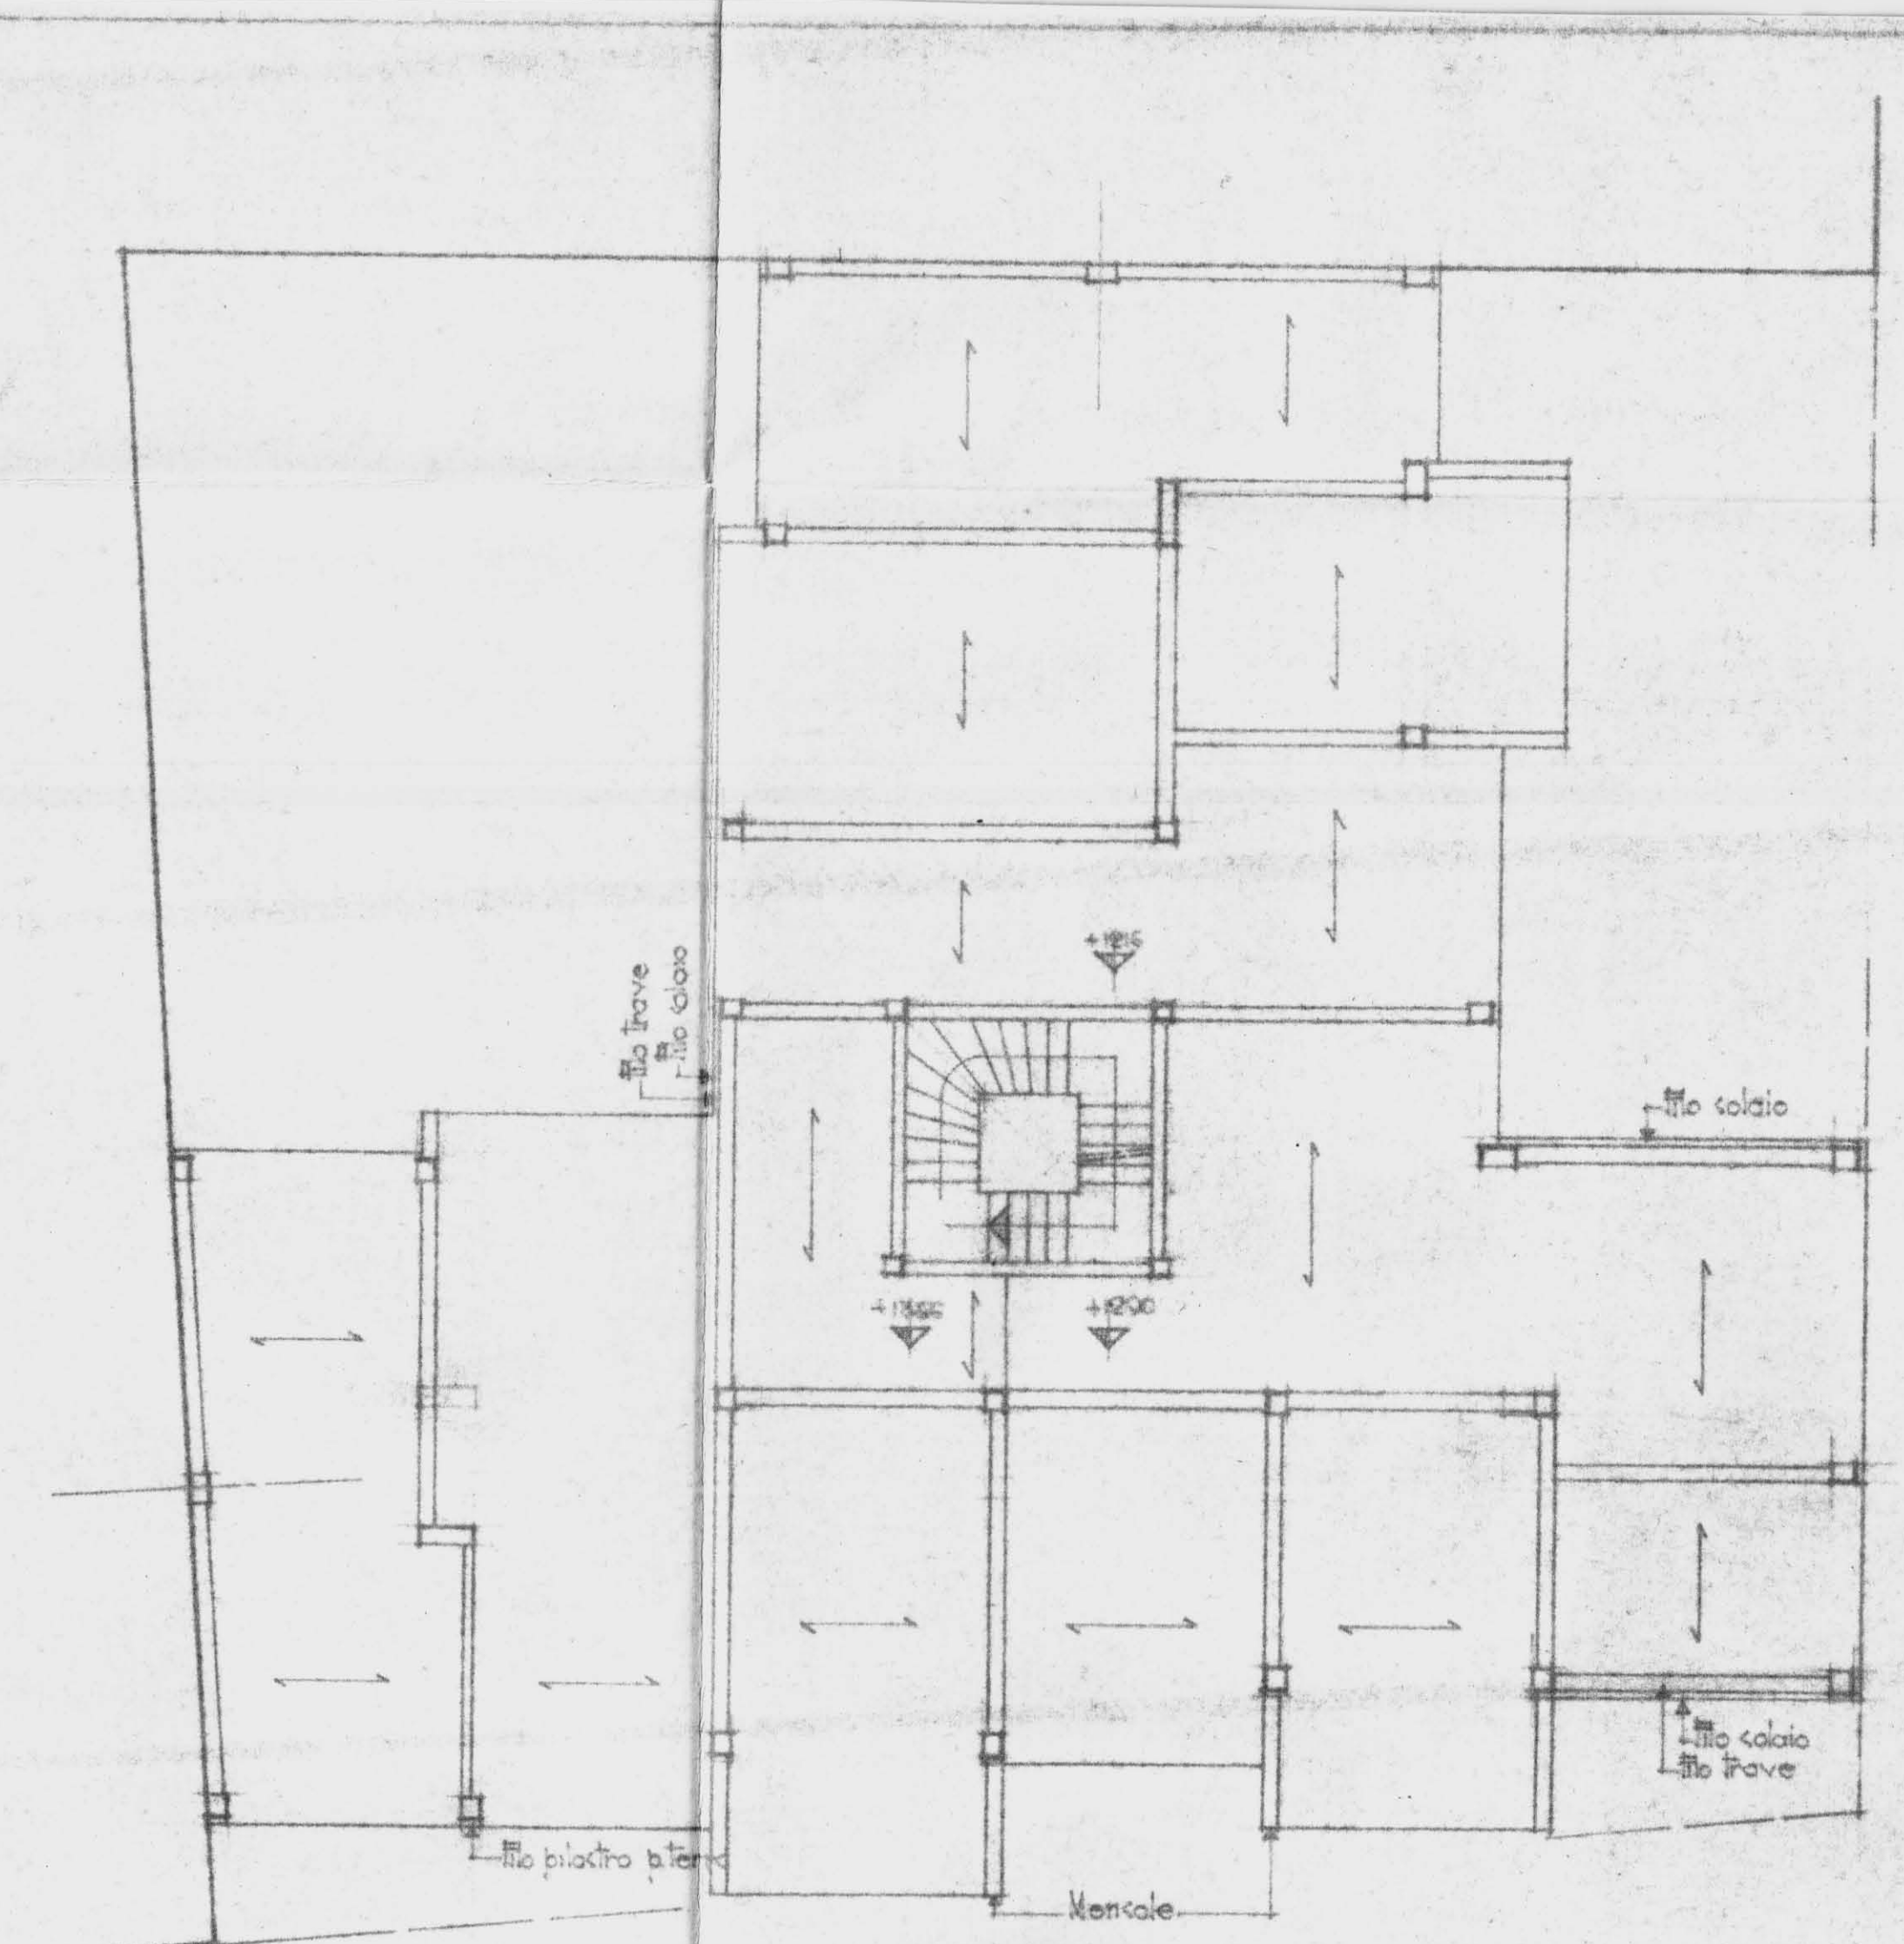

SCHEMA STRUTTURE
Scala 1:100

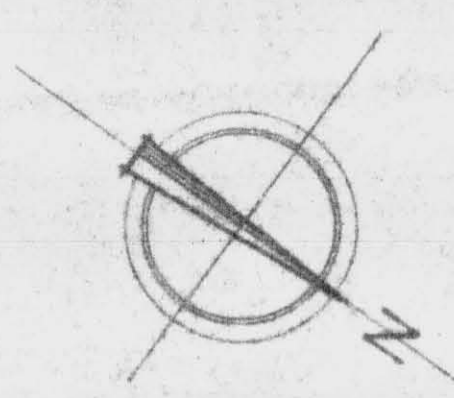

PIANO FIDUCIARIO DI OCCUPAZIONE OPERALE GESTIONE IN A. CASA P.A. ART. 10, 11, 12, 99, 100	TAV. N° 1
COOPERATIVA MINERVA	Scala 1:50
PIANTA PIANO TERRA	DATA 15-6-1950
PROGETTISTI: ARCH. C. AYMORINO ING. F. CICIRILLO ING. G. MARASCO	

Firma ingegnere al 10/2/50